
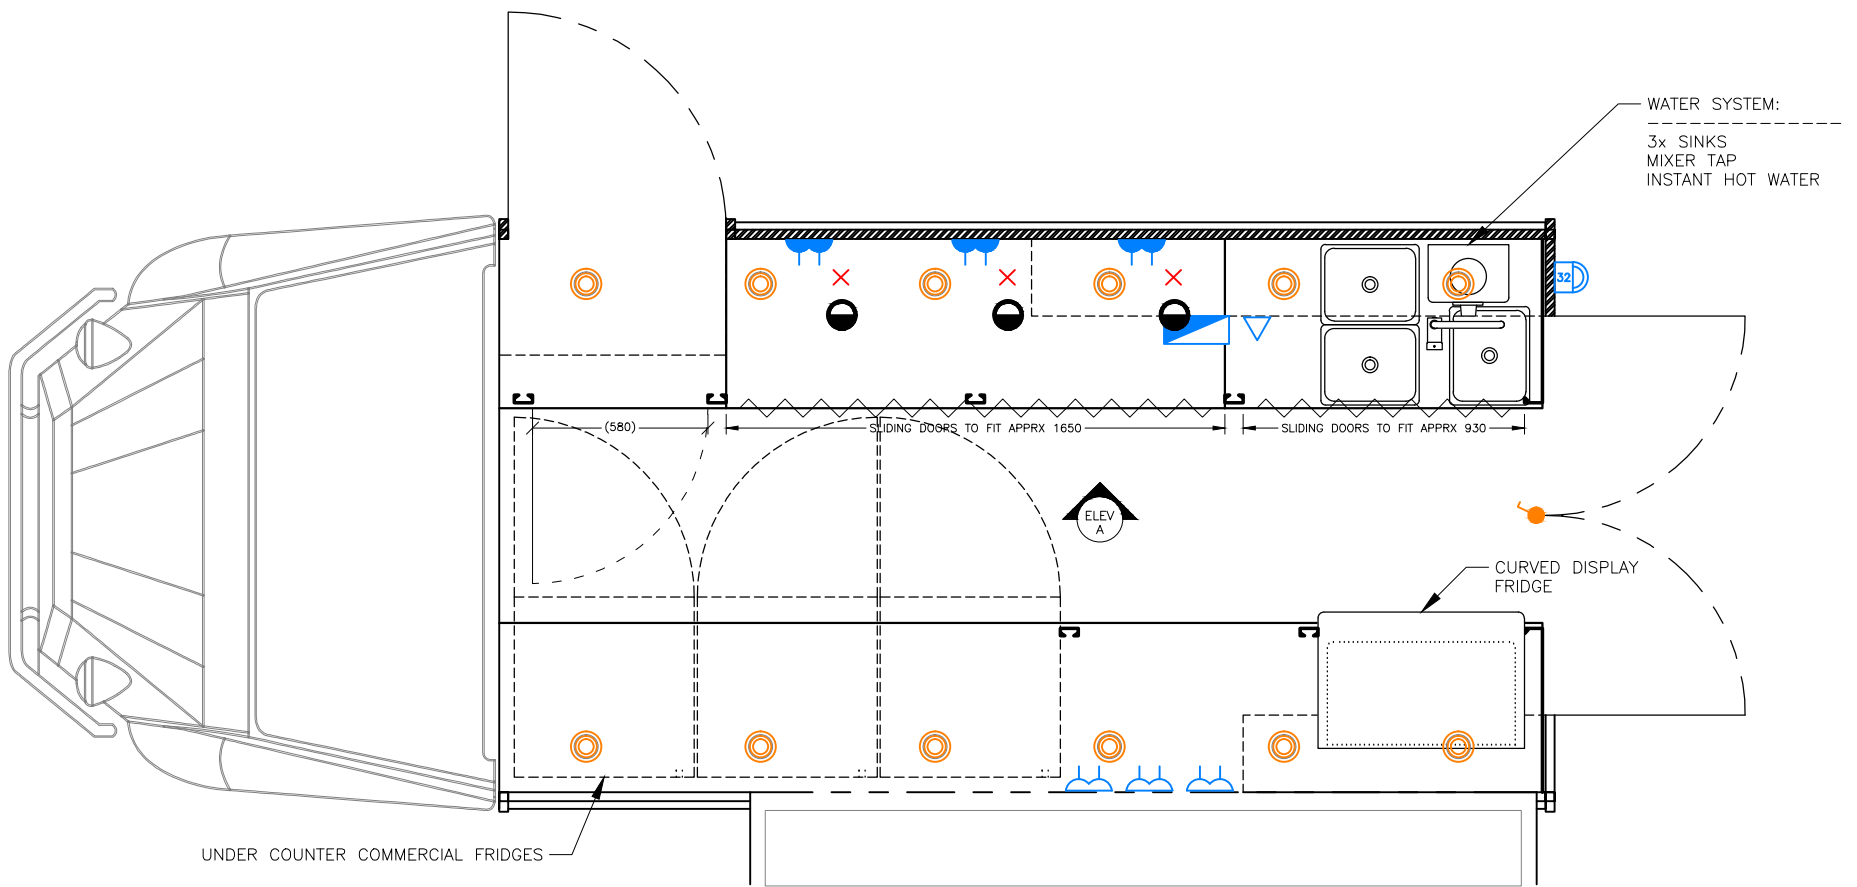


ELEVATION A:
OFFSIDE COUNTER

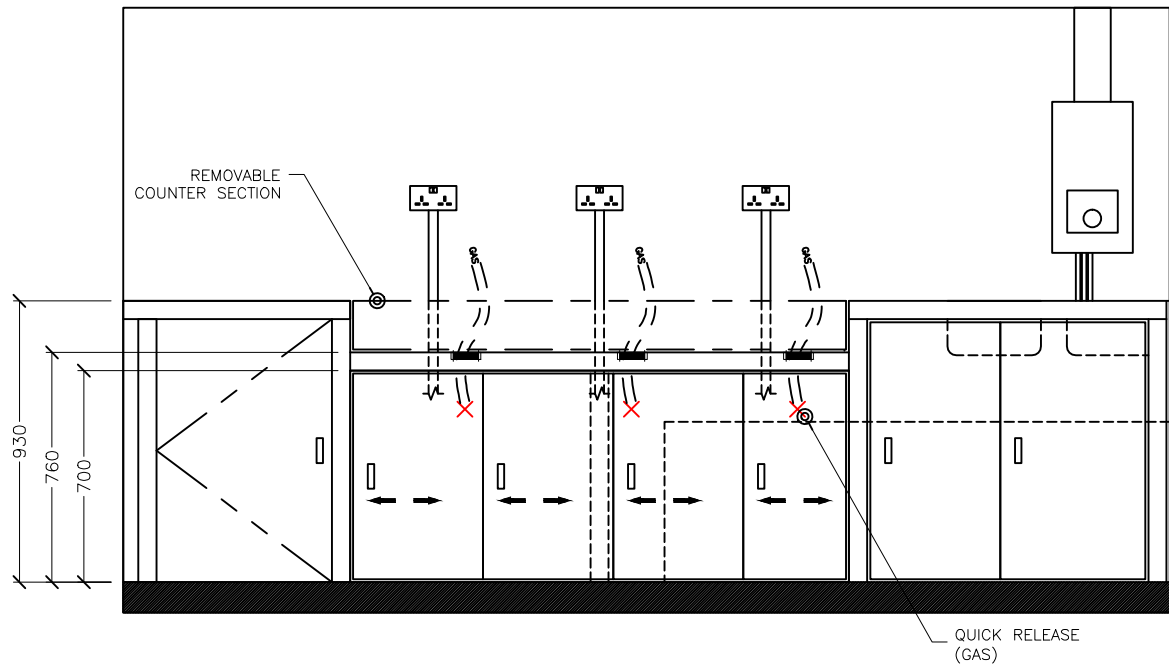

ELECTRICAL LEGEND

		DOUBLE SWITCHED SOCKET
		SINGLE SWITCHED SOCKET
		SWITCHED FUSED CONNECTION BOX
		SWITCHED FUSED CONN. BOX WITH LAMP
		FUSED CONNECTION BOX (UNSWITCHED)
		SINGLE UNSWITCHED CEE 7/4 "SCHUKO"
		ONE WAY SWITCH - SINGLE POLE
		IEC 60309 INLET / OUTLET
		SWITCH DISCONNECTOR (ISOLATOR)
		45 A COOKER SWITCH
		DATA SOCKET
		12 V CIGAR SOCKET
		MECHANICAL CONTROL PANEL
		DISTRIBUTION BOARD
		INVERTER
		SINGLE LED/FLU BATTEN (VALUE = LENGTH)
		CONTACTOR
		FAN CONTROL
		CEILING MOUNTED LED SPOTLIGHT
		CABLE TIDY (HORIZONTAL / VERTICAL)
		IP RATED ACCESSORY BOX

----	----	----
----	----	----
----	----	----
----	----	----
----	----	----
REV	DESCRIPTION	DATE

TYP (UNLESS STATED)	
ANGLES	90°
DIMENSIONS	EXTERNAL
PROJECTION	
TOLERANCES	± 1mm
PRINT	SCALE UNITS
A3	NTS mm
CAD	CHK
I.J	A.McG

JOB NUMBER
J0404

JOB TITLE VINTAGE FOOD TRUCKS - CONVERSION		
DRAWING TITLE GENERAL INTERNAL LAYOUT		
DRAWING NUMBER	REV	DATE MODIFIED
J0404-A1	----	21/03/2016 16:27